

GENERAL NOTES
 ALL INTERIOR DIMENSIONS INCLUDING CEILING HEIGHTS ARE TAKEN TO AND FROM FINISHED SURFACES UNLESS OTHERWISE STATED. ALL LEVELS AND DIMENSIONS MUST BE CHECKED ON SITE. ANY DISCREPANCIES WITH THE INFORMATION DISPLAYED IN THIS DRAWING MUST BE REPORTED IN WRITING. RESPONSIBILITY CANNOT BE ACCEPTED FOR ANY ERRORS MADE TO THIS DRAWING WITHOUT PRIOR PERMISSION.
 THIS DRAWING MUST NOT BE REPRODUCED, COPIED, SCALED OR REPRODUCED OTHERWISE WITHOUT THE WRITTEN PERMISSION OF THE SURVEYOR.
 ACCURACY CANNOT BE GUARANTEED. THE DRAWING SHALL NOT BE USED IN ANY CIRCUMSTANCES FOR ANY STRUCTURAL CALCULATION OR BUILDING CONSTRUCTION / DEMOLITION WORK.

SURVEY GRID

- PLEASE NOTE THAT GRID SHOWN ON THIS DRAWING IS AS FOLLOWS
- ARBITRARY
 - ARBITRARY BUT APPROXIMATELY RELATED TO GRID NORTH
 - BEST FIT TO ORDNANCE SURVEY DIGITAL DATA
 - ORDNANCE SURVEY NATIONAL GRID USING UPS

LEVELS AND HEIGHTS

- AS ARCH-SUPPORTER HEIGHT
 - AV ARCH-HEAD HEIGHT
 - B BEAM SOFFIT HEIGHT
 - C CEILING SOFFIT HEIGHT
 - D DOOR HEAD HEIGHT
 - FL FLOOR LEVEL
 - F FLOOR HEIGHT
 - S SOFFIT HEIGHT
 - T TRUNNING HEIGHT
 - WS WINDOW SILL HEIGHT
 - WW WINDOW HEAD-HEIGHT
- PLEASE NOTE ALL HEIGHTS TAKEN FROM FLOOR/SLAB UNLESS OTHERWISE STATED

DATUM: ARBITRARY
 DESCRIPTION: N/A
 N/A

SYMBOLS


	Survey Point		Wall
	Level Marker		Window Sill
	Window Head		Window Head
	Door Head		Door Head
	Floor Level		Floor Level
	Ceiling Soffit		Ceiling Soffit
	Beam Soffit		Beam Soffit
	Arch-Supporter Height		Arch-Head Height
	Electrical Socket		Electrical Socket
	Lamp Post		Lamp Post
	Manhole		Manhole
	Notice Board		Notice Board
	No Further Information		No Further Information

ABBREVIATIONS (Where Applicable)

AB	AIR BRICK	OH	OVER-HEAD
AQU	AIR CONDITIONING UNIT	PLT	PAVEMENT LIGHT
BA	BALLARD	R	RADIATOR
BRW	BRICK WALL	RS	ROAD GULLY
BT	BRITISH TELECOM	RH	RADIATOR HOUSING
CATV	CABLE TELEVISION COVER	RNB	ROAD NAME BOARD
CE	CLEANING EYE	RS	ROAD SIGN
CL	COVER LEVEL	RW	REINFORCING WALL
CPB	CONC PAVING SLABS	RWP	RAINWATER PIPE
CP	DOWN PIPE	SC	STOP COOK
ECF	ELECTRIC CABLE FIT	SO	SECONDARY GLAZING
EP	ELECTRICITY POLE	SV	STOP VALVE
FR	FIRE RISER	T	TRUNNING
G	GULLY	TIC	TELECOM INSPECTION COVER
GSC	GAS STOP COOK	TD	TRAP DOOR COVER
GV	GAS VALVE	TLT	TRAFFIC LIGHT
HWC	HOT WATER CYLINDER	TP	TRUSSELY PILE
HTR	HEATED TONEL RAIL	TPS	TACTILE PAVING SLABS
IC	INSPECTION COVER	UTL	UNABLE TO LIFT
LP	LAMP POST	V	VENT
MH	MANHOLE	VP	VENT PIPE
MW	MANHOLE	W	WINDOW
NB	NOTICE BOARD	WM	WATER METER
NFI	NO FURTHER INFORMATION	WP	WASTE PIPE

FENCE TYPES AND ABBREVIATIONS (Where Applicable)

BWC	BARRIER WIRE	R	IRON RAILINGS
B	CLOSE BOARDING	PR	POST RAIL
CI	CORRUGATED IRON	PW	POST WIRE
CLX	CHAIN LINK	OB	OPEN BOARDING
CPS	CHESTNUT PALING	WM	WIRE MESH

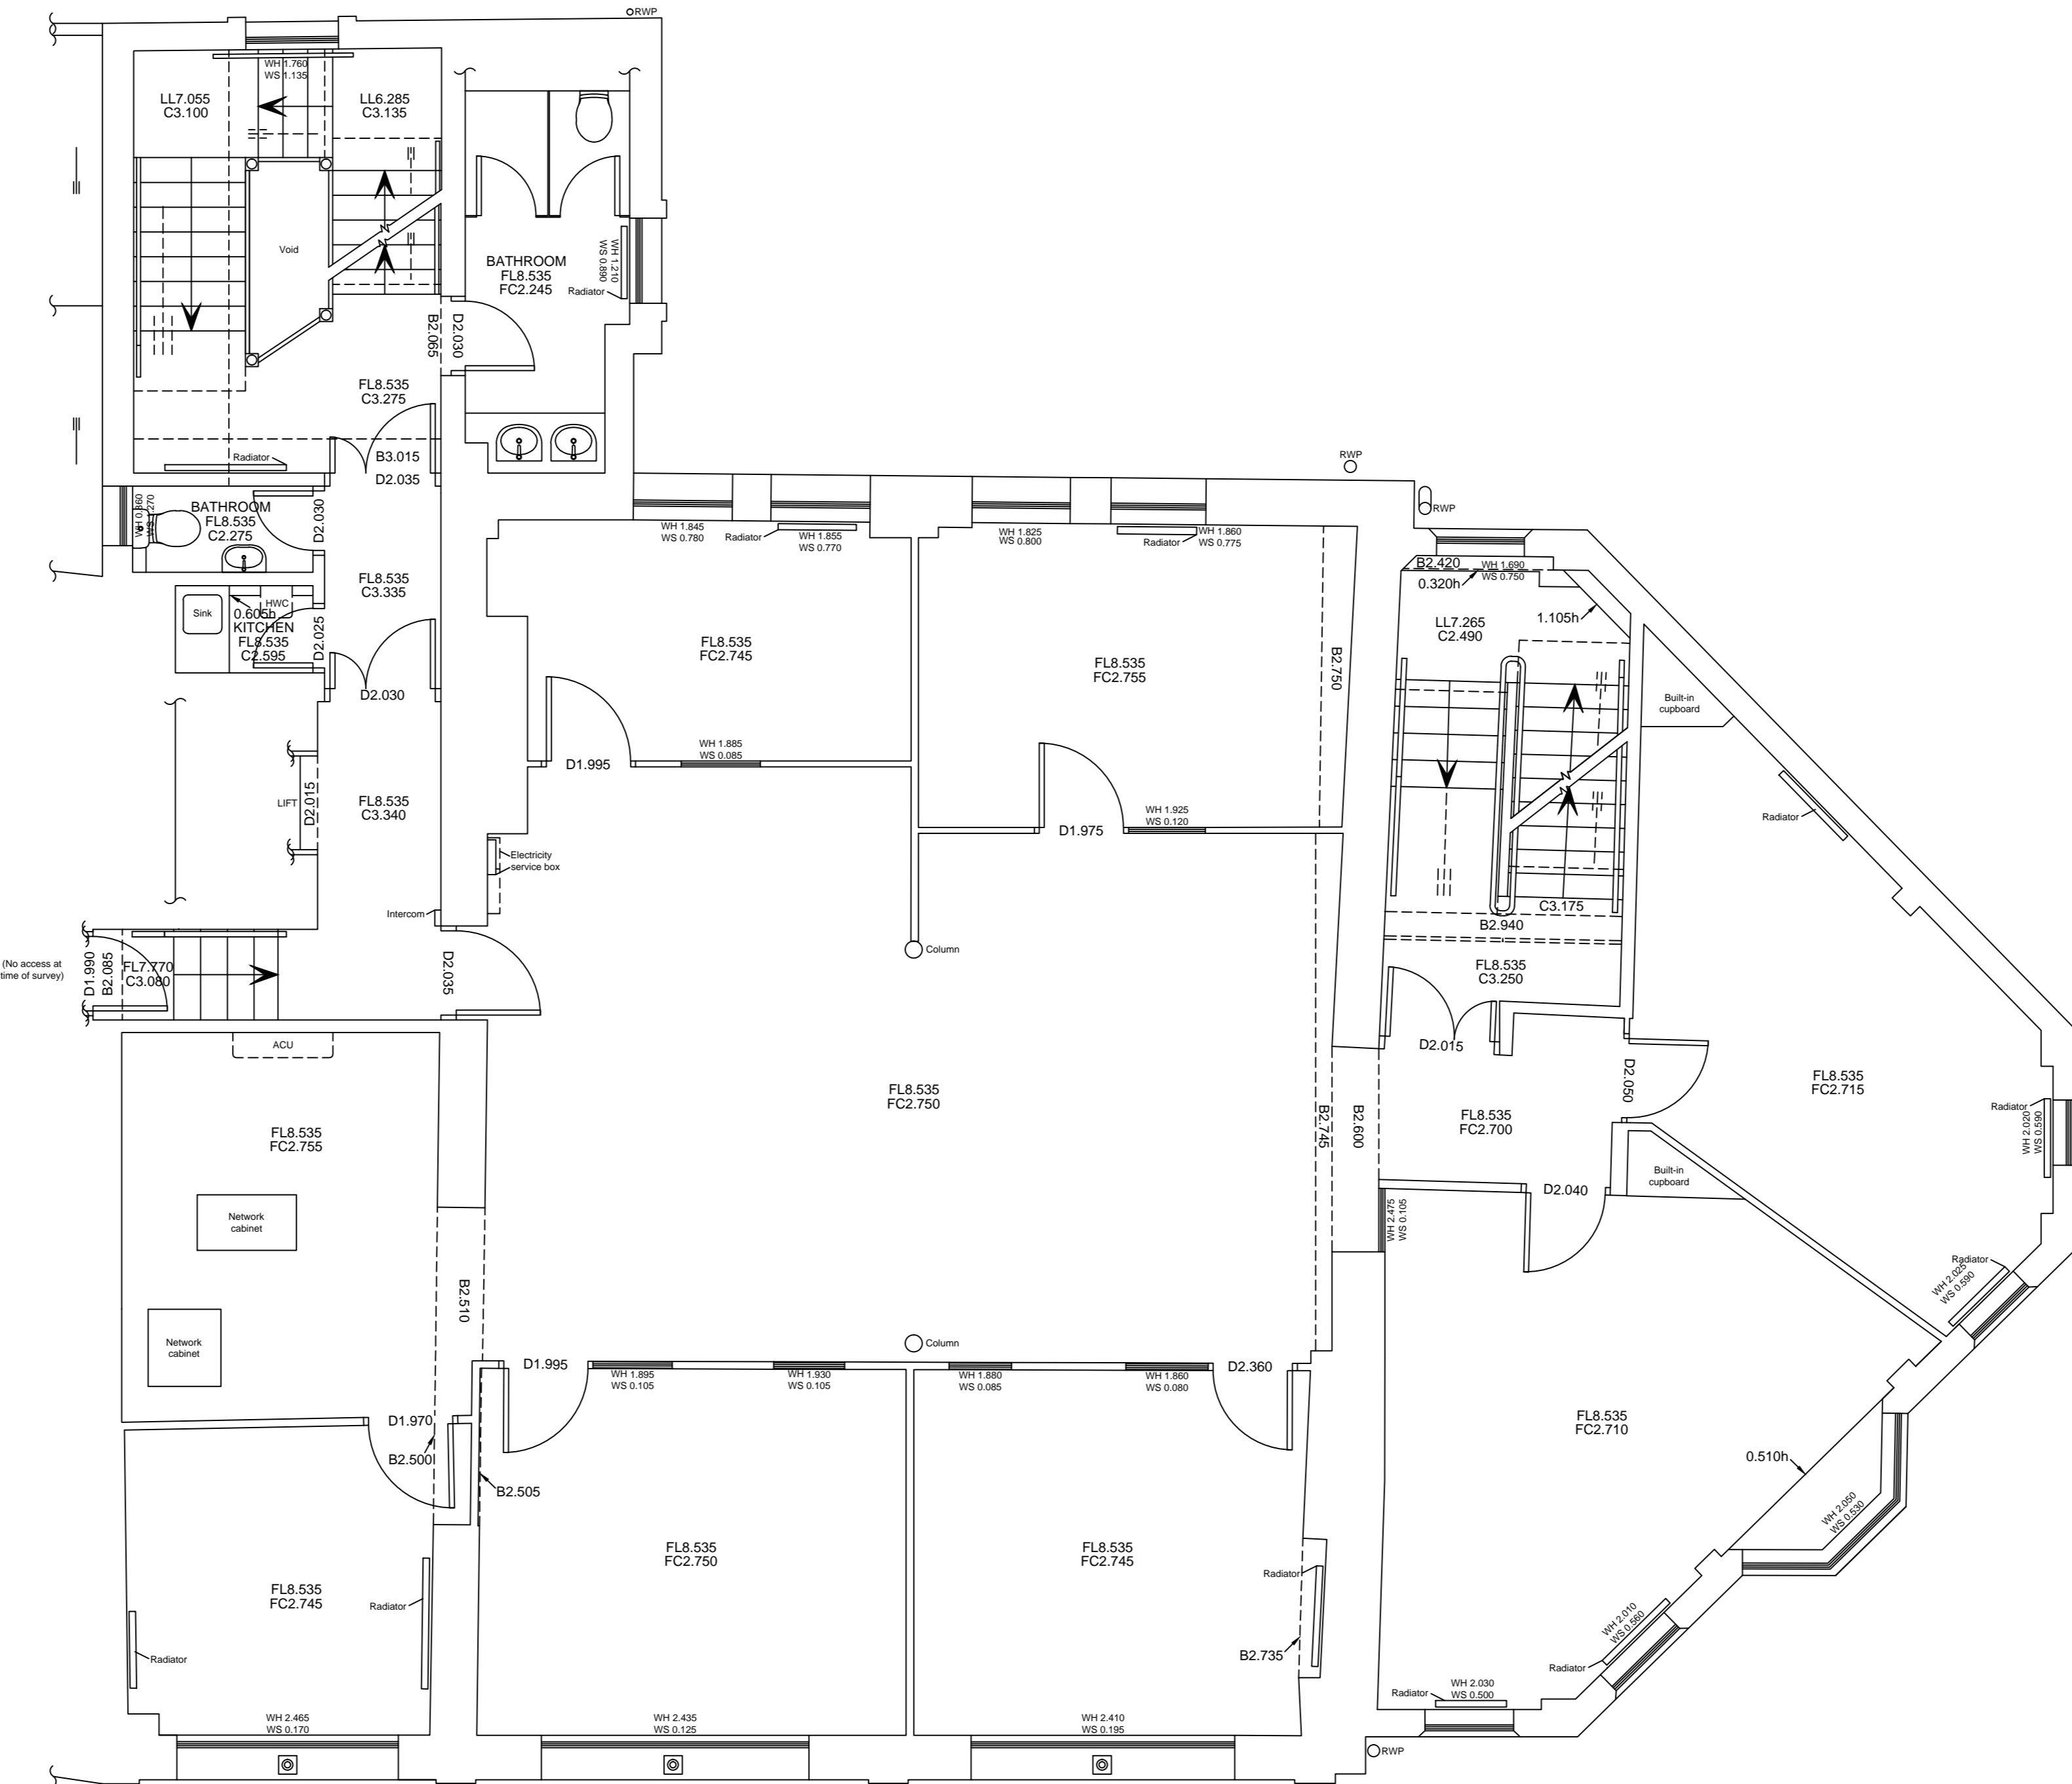

FIRST FLOOR PLAN

PROJECT TITLE
**ST. AUGUSTINE COURT
 BRISTOL
 BS1 4UL**

DRAWING TITLE
FIRST FLOOR



SCALE	SIZE	DRAWING
1:50	A0	313880

DRAWN	CHECKED	DATE
BC	HR	APRIL 2023